

REV	DESCRIPTION	DATE
0	ISSUED FOR PERMIT	5-14-19

TRUE NORTH:

 
STATE OF MAINE
ROBERT B. SPRINK
14368
LICENSED PROFESSIONAL ENGINEER
05/19/19

SMRT Architects and Engineers
144 Fore Street P.O. BOX 618
Portland, Maine 04104
1-877-700-7678
www.smrtinc.com

RANSOM Consulting Engineers and Scientists
Ransom Consulting Engineers and Scientists
400 Commercial Street, Suite 400
Portland, Maine 04103

NORDIC AQUAFARMS
285 NORTHPORT AVENUE
BELFAST, MAINE

ELECTRICAL SITE PLAN
AREA C





SCALE: 1" = 30'

PROJECT MANAGER:	ADB	PROJECT NO.:	18076
A/E OF RECORD:			
JOB CAPTAIN:	SP		
DRAWN BY:			

SMRT FILE: ES103-18076 SHEET No. **ES103**

NOT FOR CONSTRUCTION

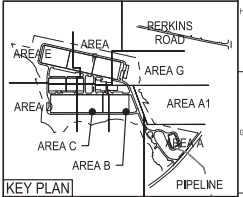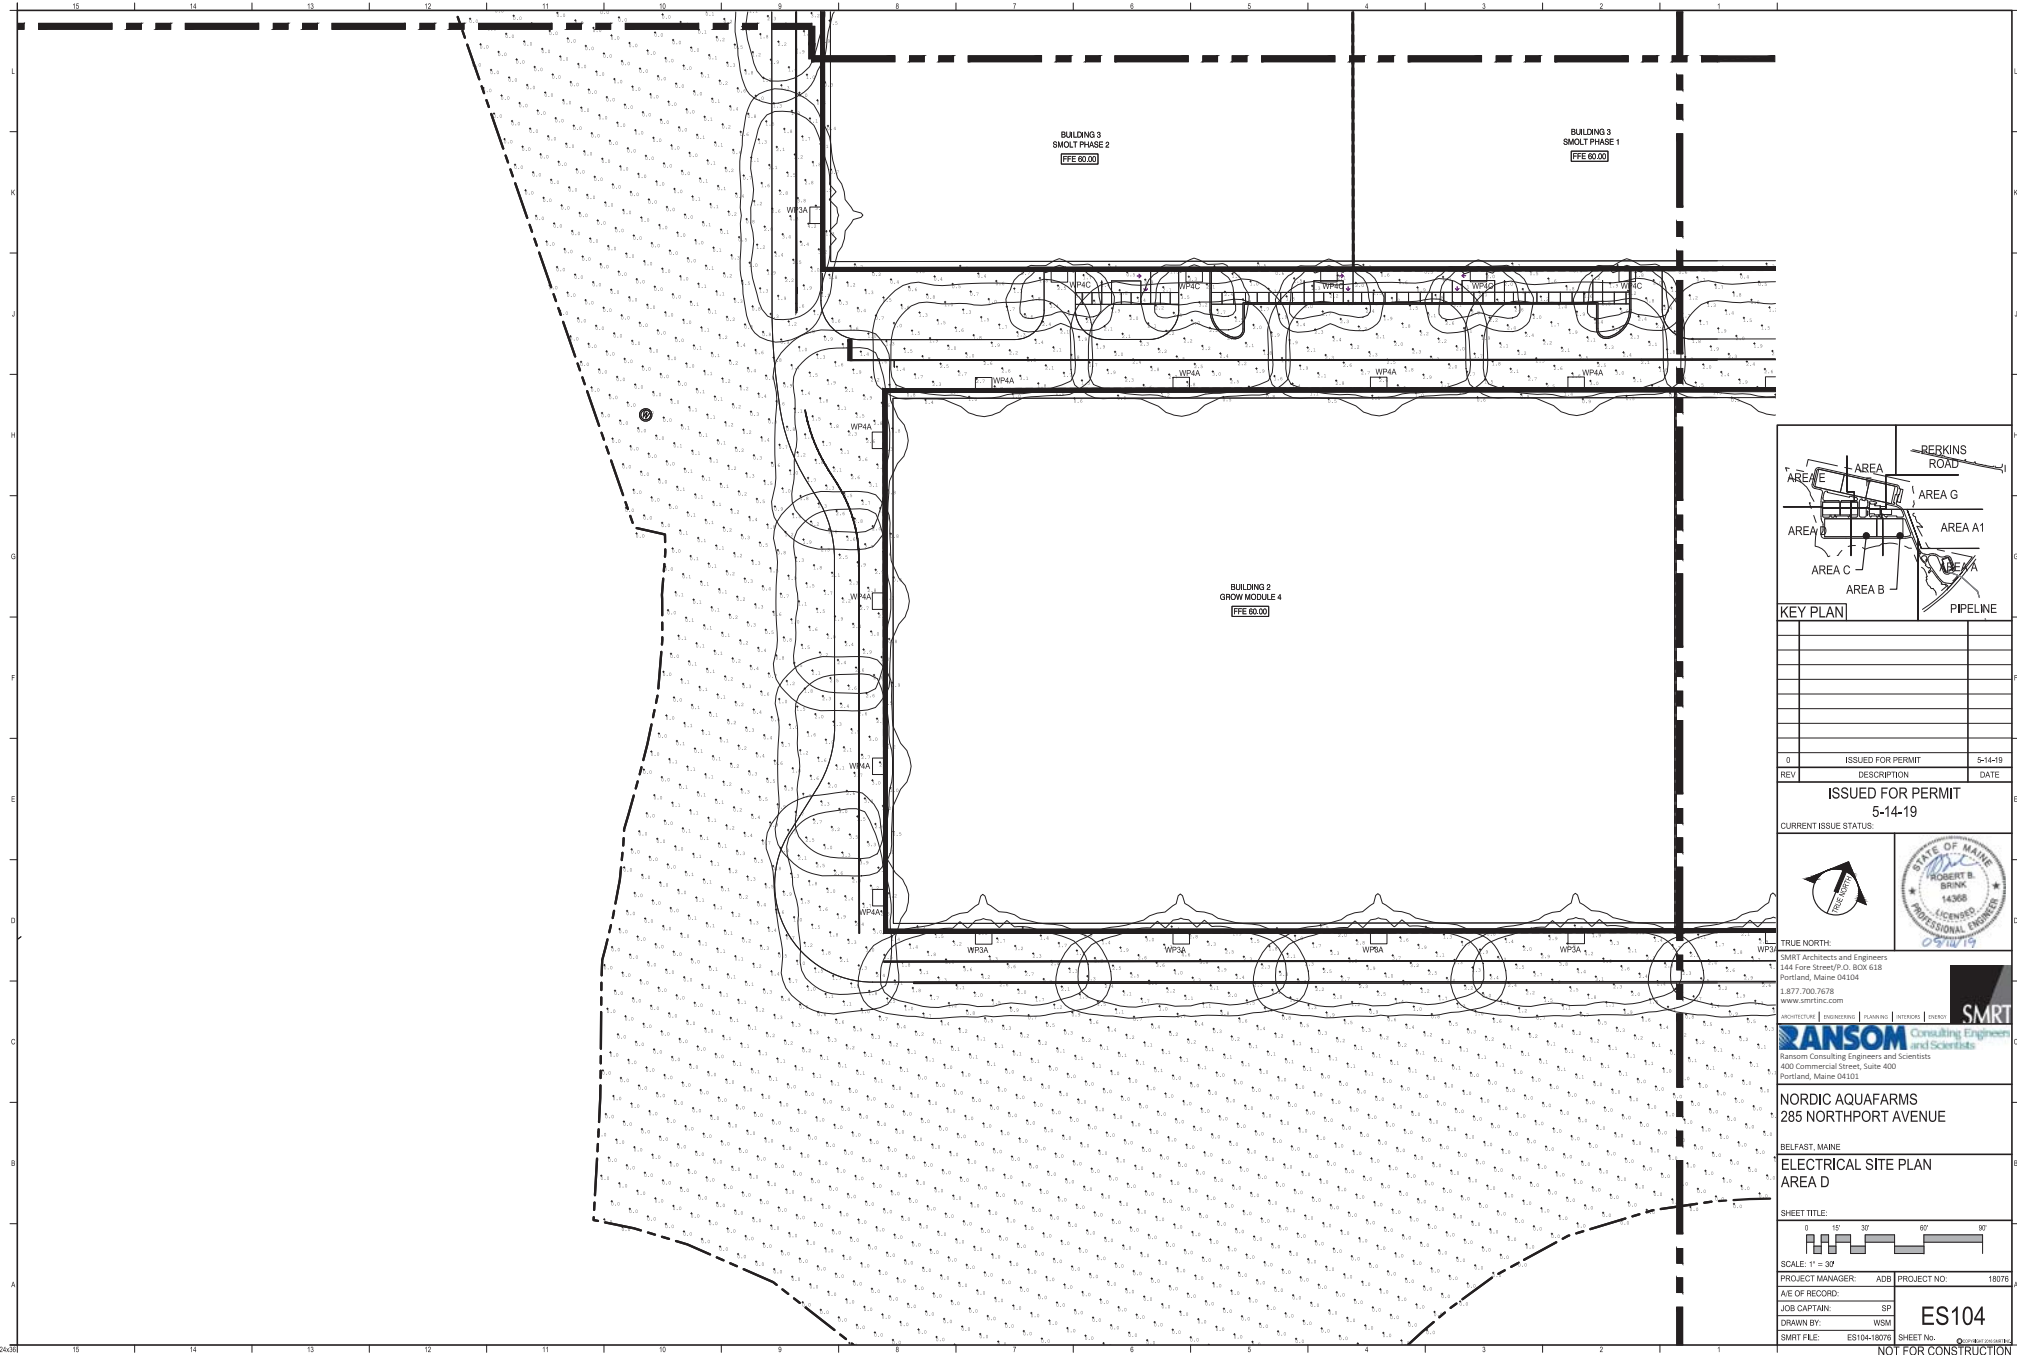

REV	DESCRIPTION	DATE
0	ISSUED FOR PERMIT	5-14-19

ISSUED FOR PERMIT
5-14-19

CURRENT ISSUE STATUS:

 


TRUE NORTH:
 SMRT Architects and Engineers
 144 Fore Street P.O. BOX 618
 Portland, Maine 04104
 1-877-700-7678
 www.smrtinc.com

RANSOM Consulting Engineers and Scientists
 Ransom Consulting Engineers and Scientists
 400 Commercial Street, Suite 400
 Portland, Maine 04103

NORDIC AQUAFARMS
 285 NORTHPORT AVENUE
 BELFAST, MAINE



ELECTRICAL SITE PLAN
AREA D



PROJECT MANAGER: ADB PROJECT NO.: 18076
 A.E. OF RECORD:
 JOB CAPTAIN: SP
 DRAWN BY: WSM
 SMRT FILE: ES104-18076 SHEET No.: 04

ES104

NOT FOR CONSTRUCTION

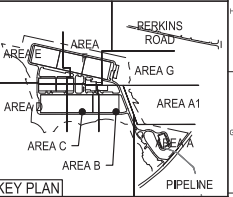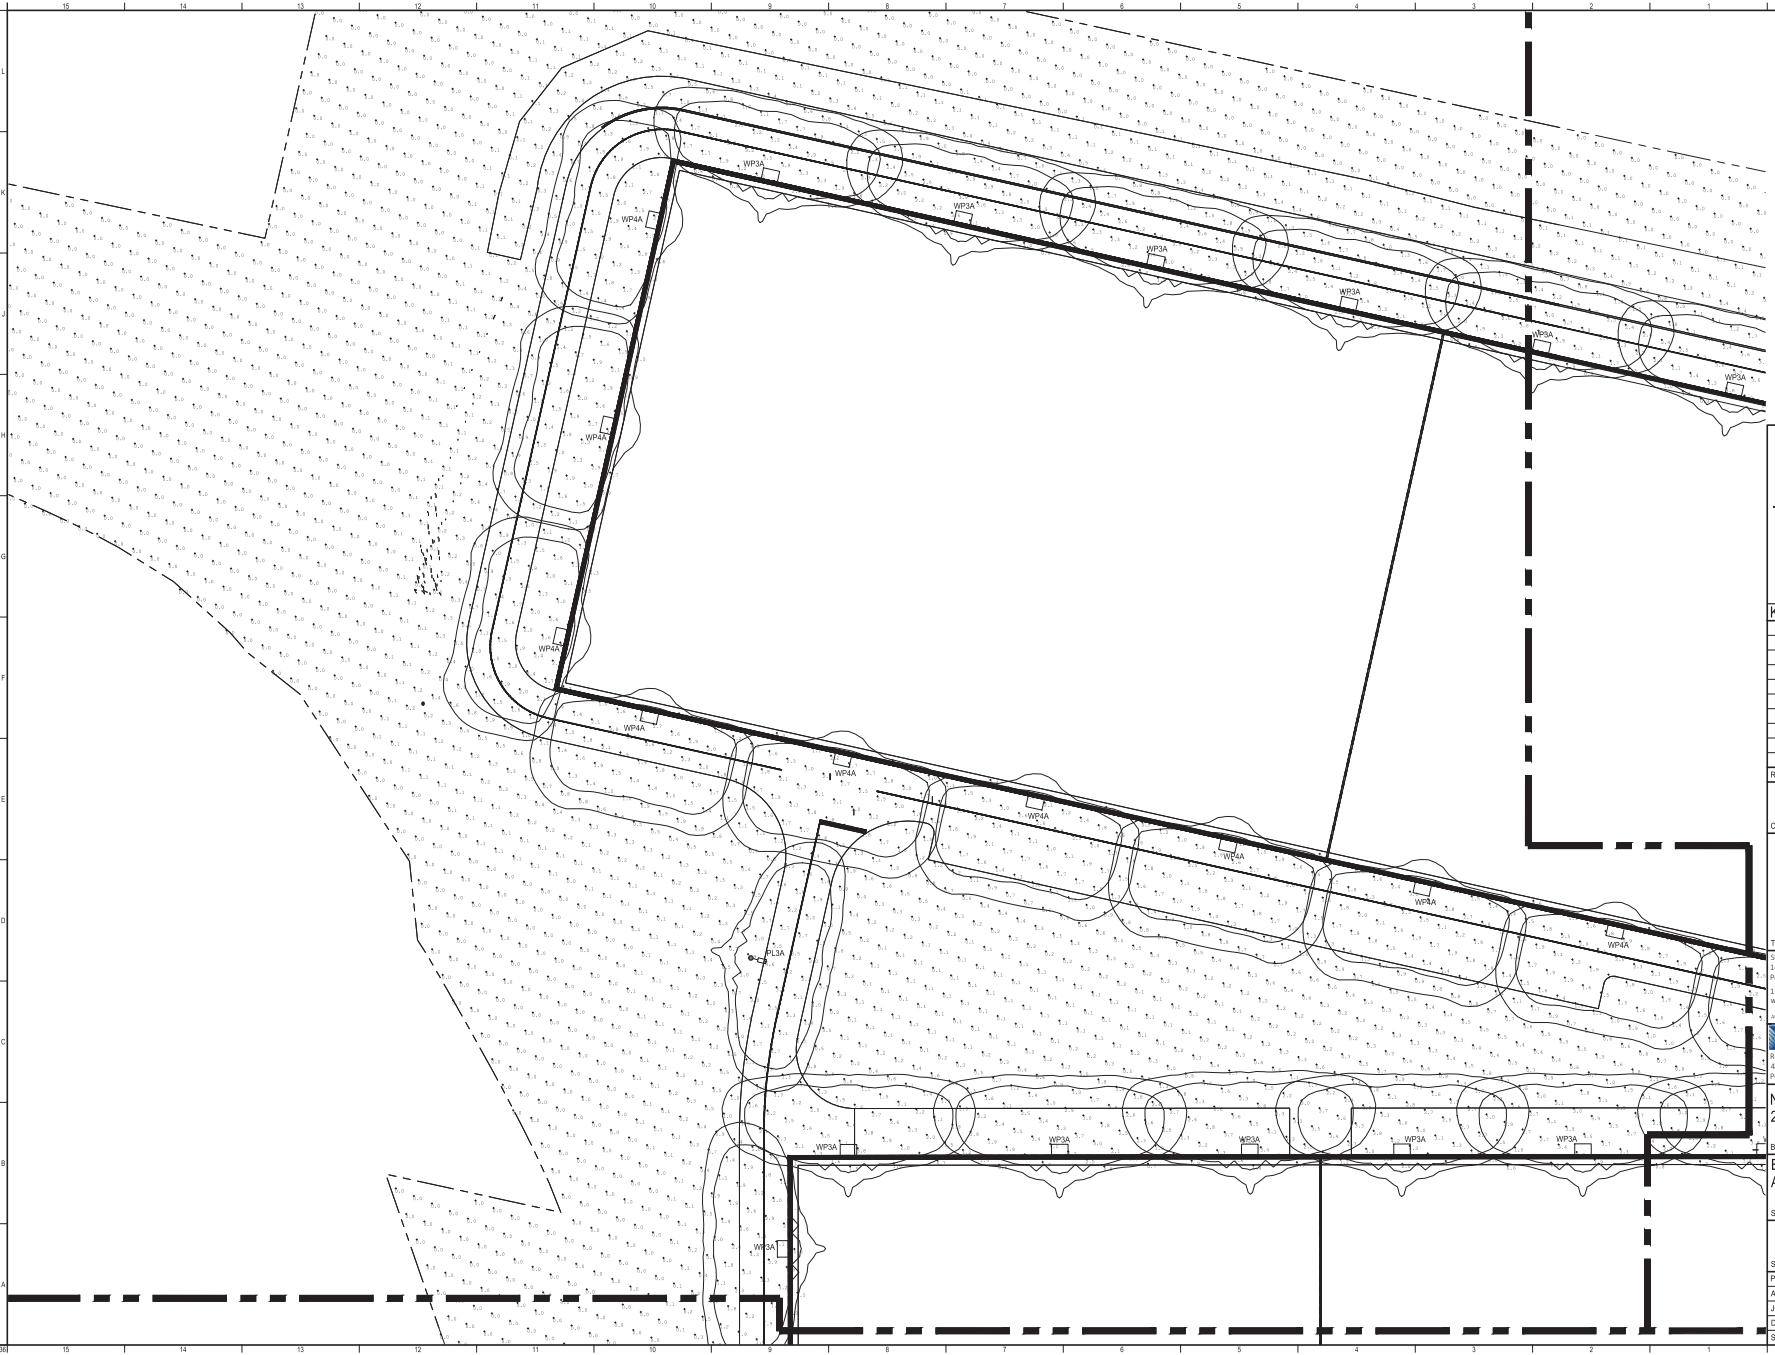

REV	DESCRIPTION	DATE
0	ISSUED FOR PERMIT	5-14-19

ISSUED FOR PERMIT
5-14-19

CURRENT ISSUE STATUS:

 
TRUE NORTH:

SMRT Architects and Engineers
144 Fore Street P.O. BOX 618
Portland, Maine 04104
1.877.700.7678
www.smrtinc.com

RANSOM Consulting Engineers and Scientists
Ransom Consulting Engineers and Scientists
400 Commercial Street, Suite 400
Portland, Maine 04103

NORDIC AQUAFARMS
285 NORTHPORT AVENUE
BELFAST, MAINE

ELECTRICAL SITE PLAN
AREA E



PROJECT MANAGER: ADB PROJECT NO. 18076

A/E OF RECORD:

JOB CAPTAIN: SP

DRAWN BY: WSM

SMRT FILE: ES106-18076 SHEET No. 02

ES105

NOT FOR CONSTRUCTION